



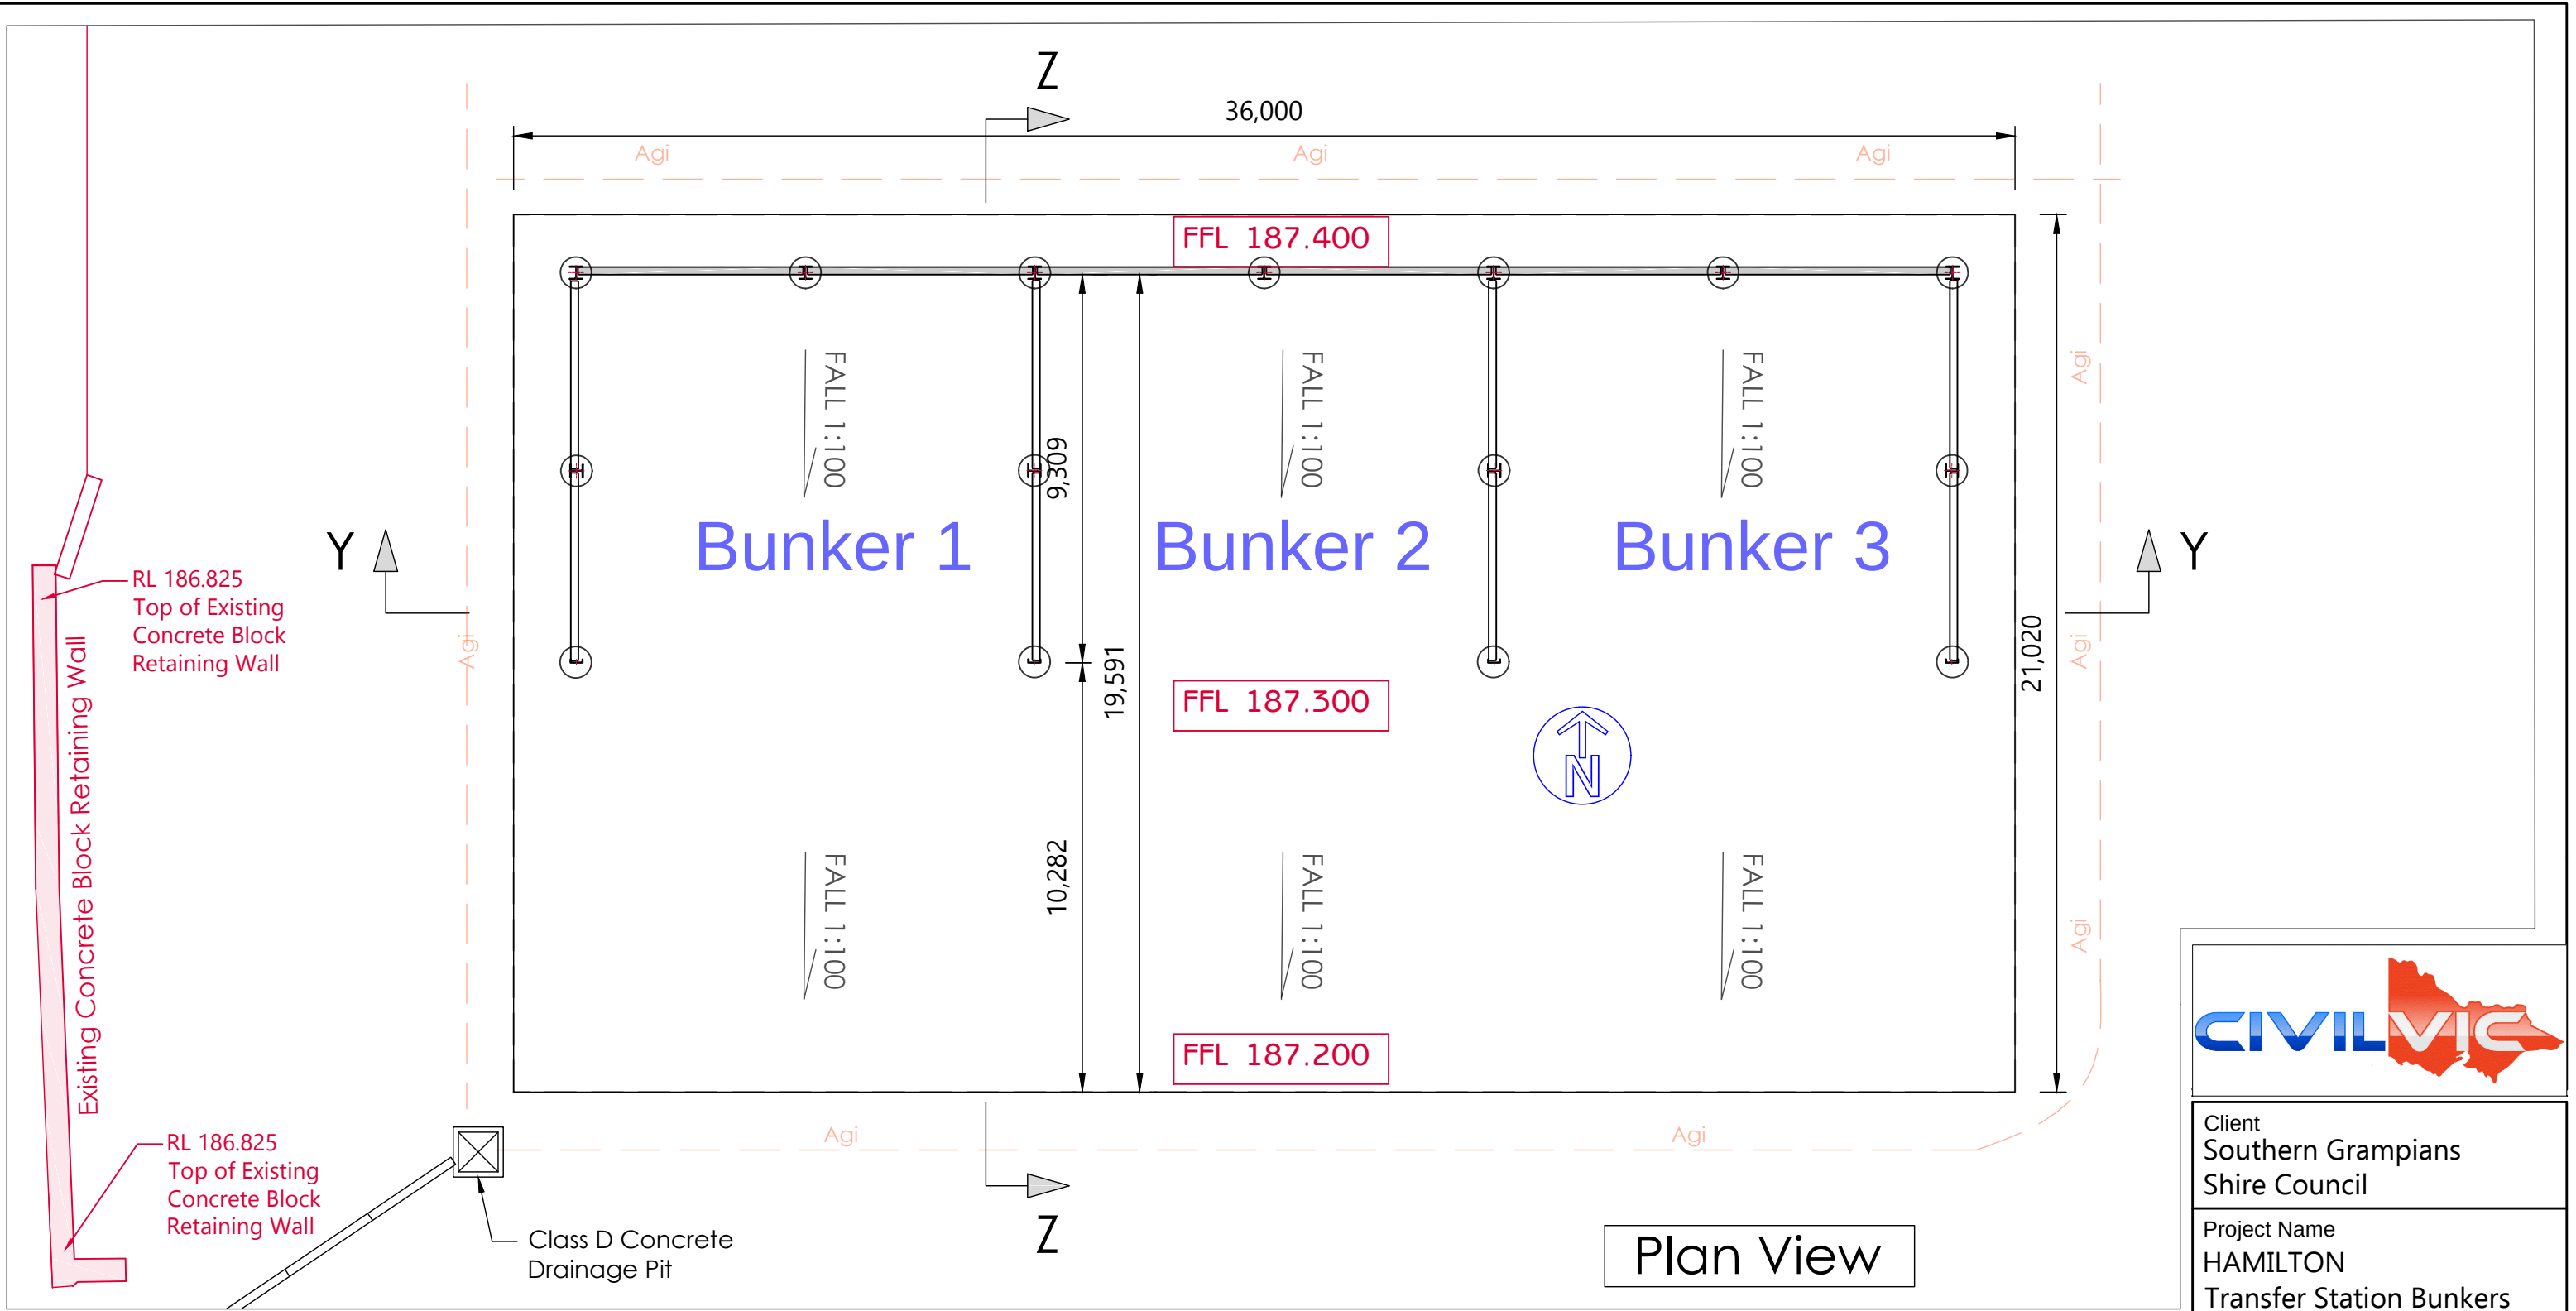



Plan View

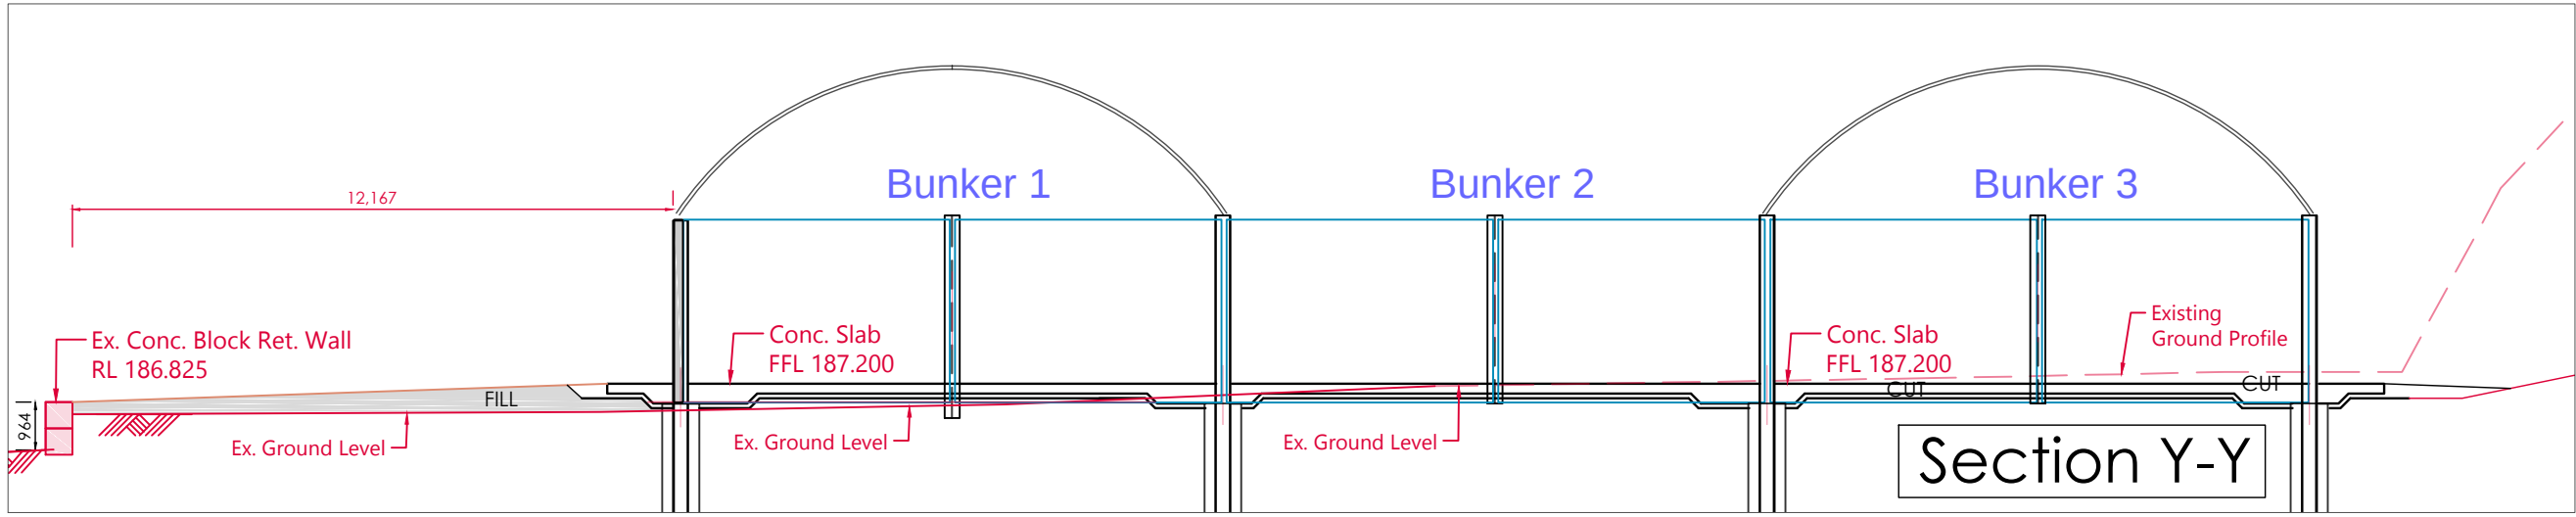

Section Y-Y



Client	Southern Grampians Shire Council
Project Name	HAMILTON Transfer Station Bunkers
Project Address	68 Elijah Street Hamilton, Vic, 3300
Drawing Name	DRAINAGE LAYOUT PLAN
Date:	30/10/2024
Drawn:	John Dordevic
Status:	Issued for Approval
Scale:	1:150
Paper Size:	A3
Drawing No.	Revision
DR1	0

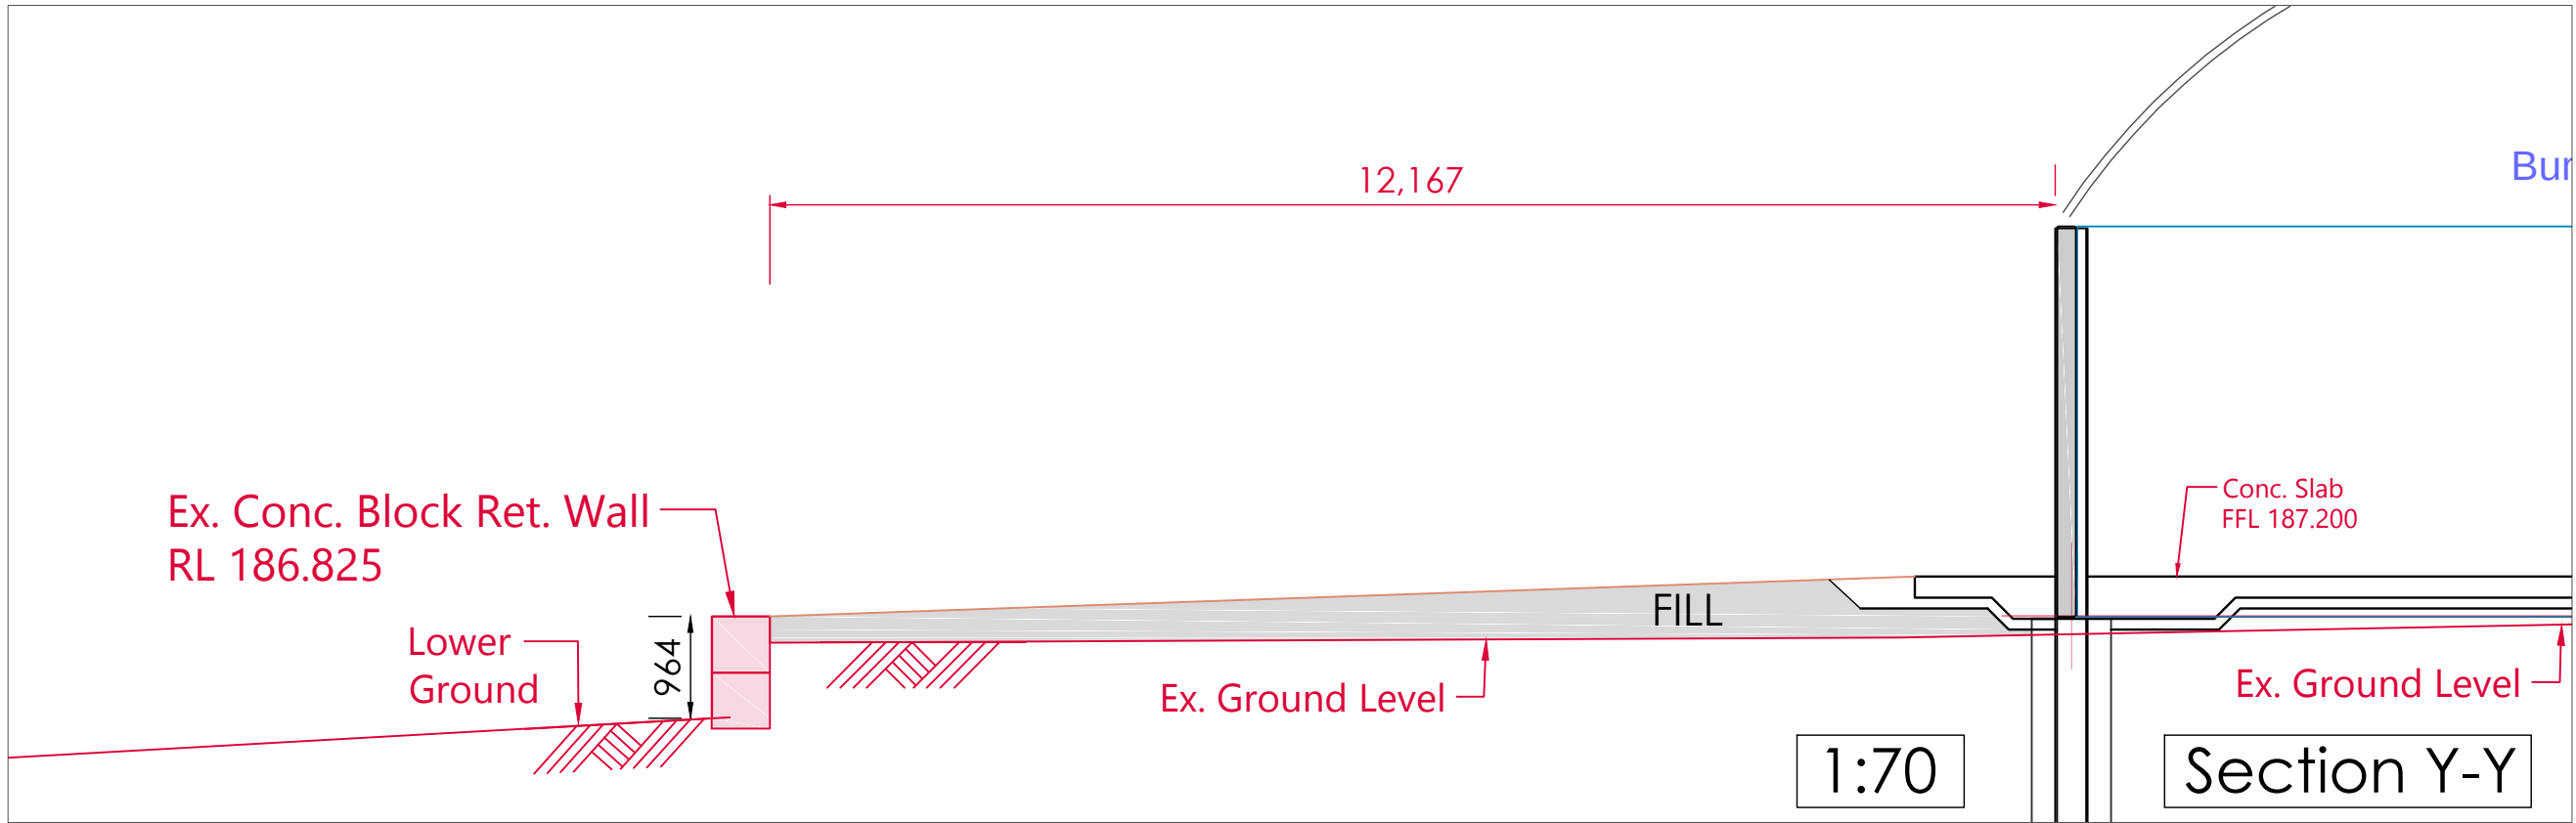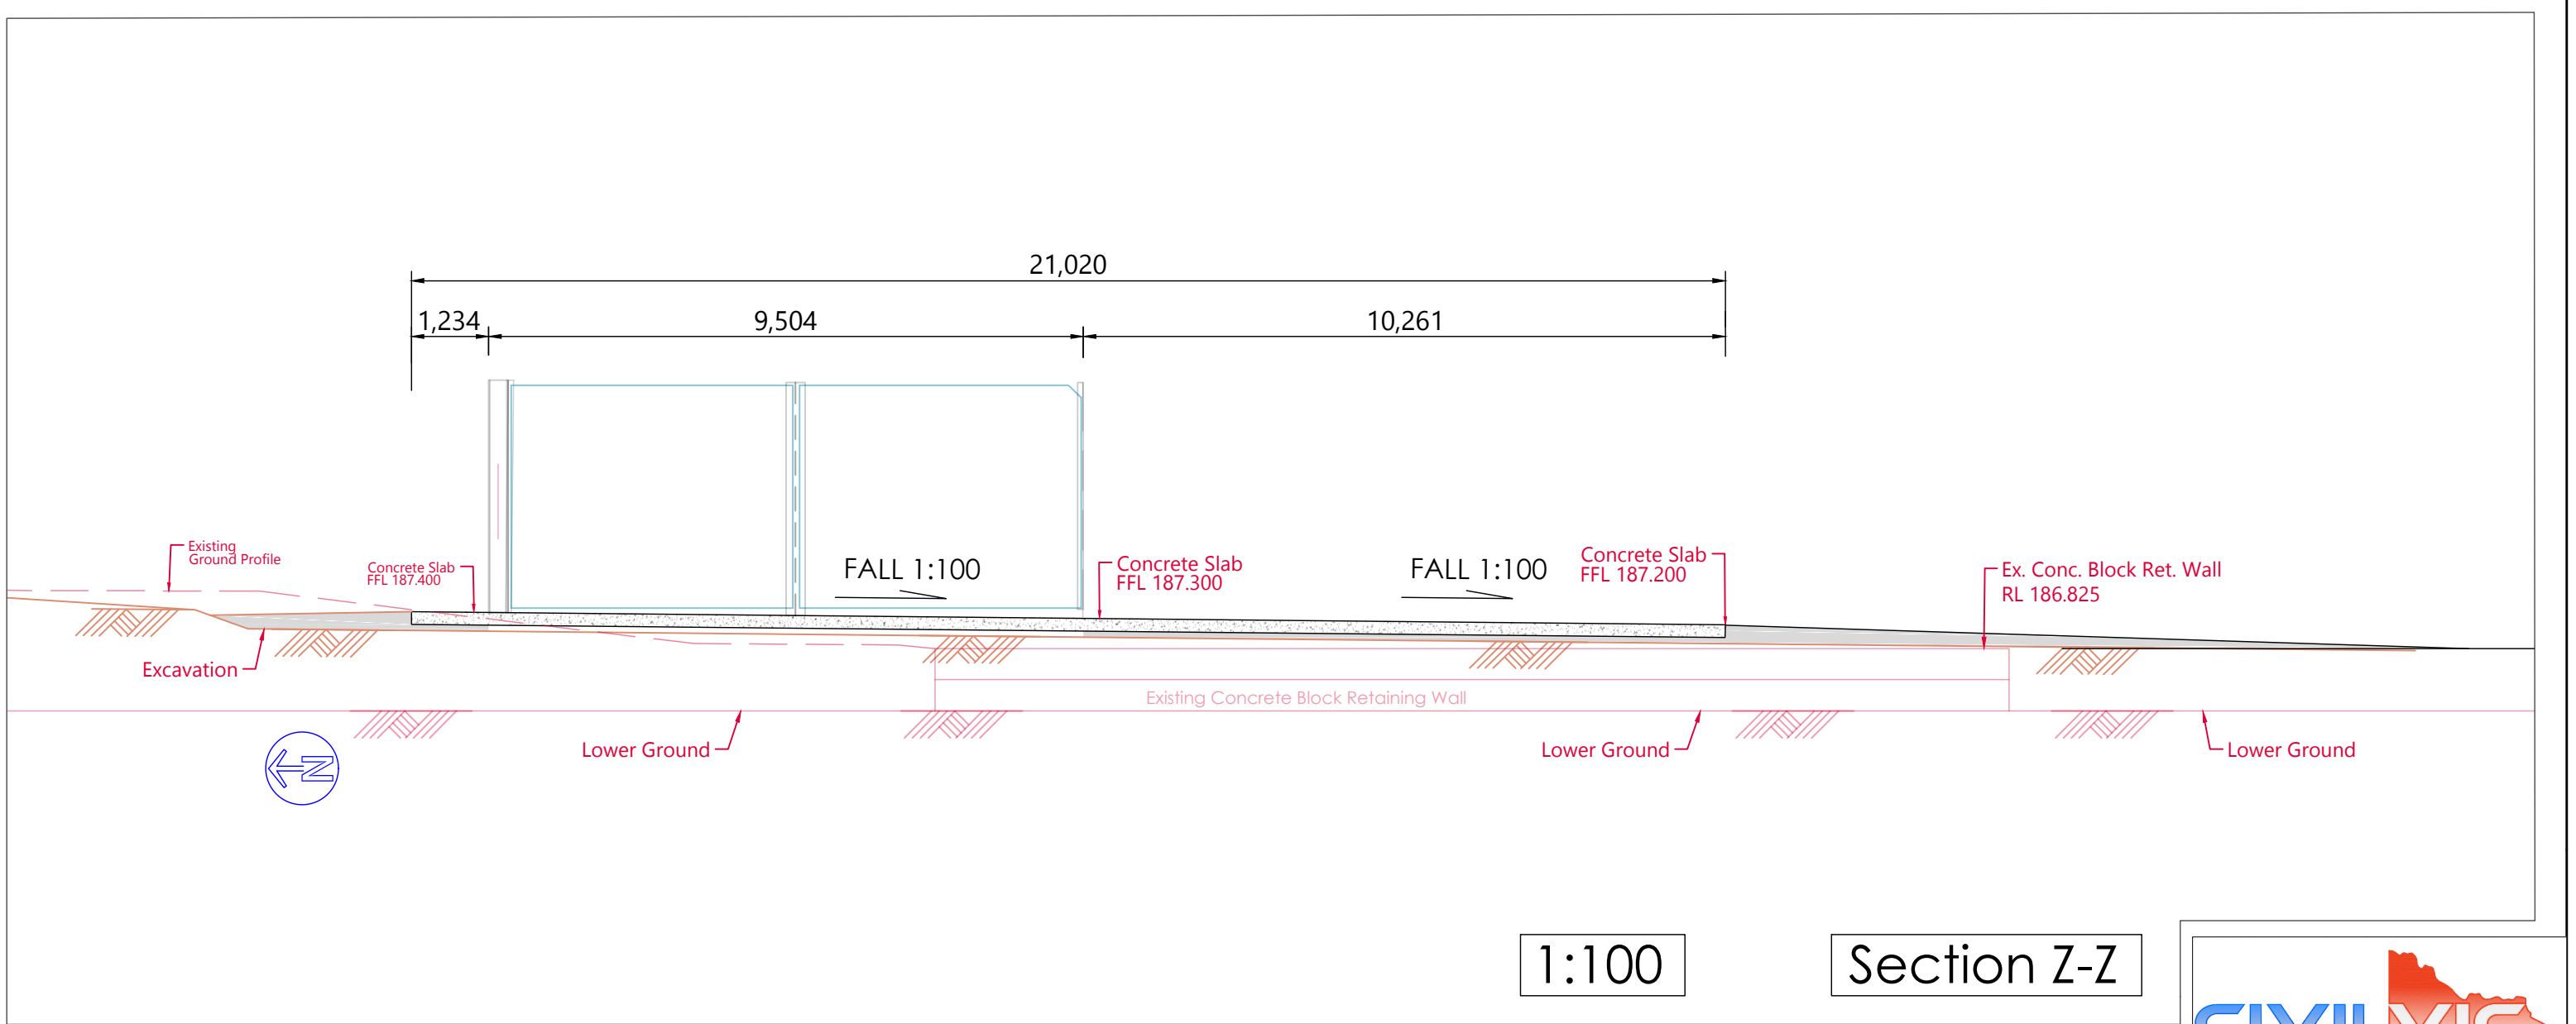

Client	Southern Grampians Shire Council
Project Name	HAMILTON Transfer Station Bunkers
Project Address	68 Elijah Street Hamilton, Vic, 3300
Drawing Name	DRAINAGE SECTIONS
Date:	30/10/2024
Drawn:	John Dordevic
Status:	Issued for Approval
Scale:	1:100, 1:70
Paper Size:	A3
Drawing No.	Revision
DR2	0